


Booth Ductwork Layout Final Location

Plan View

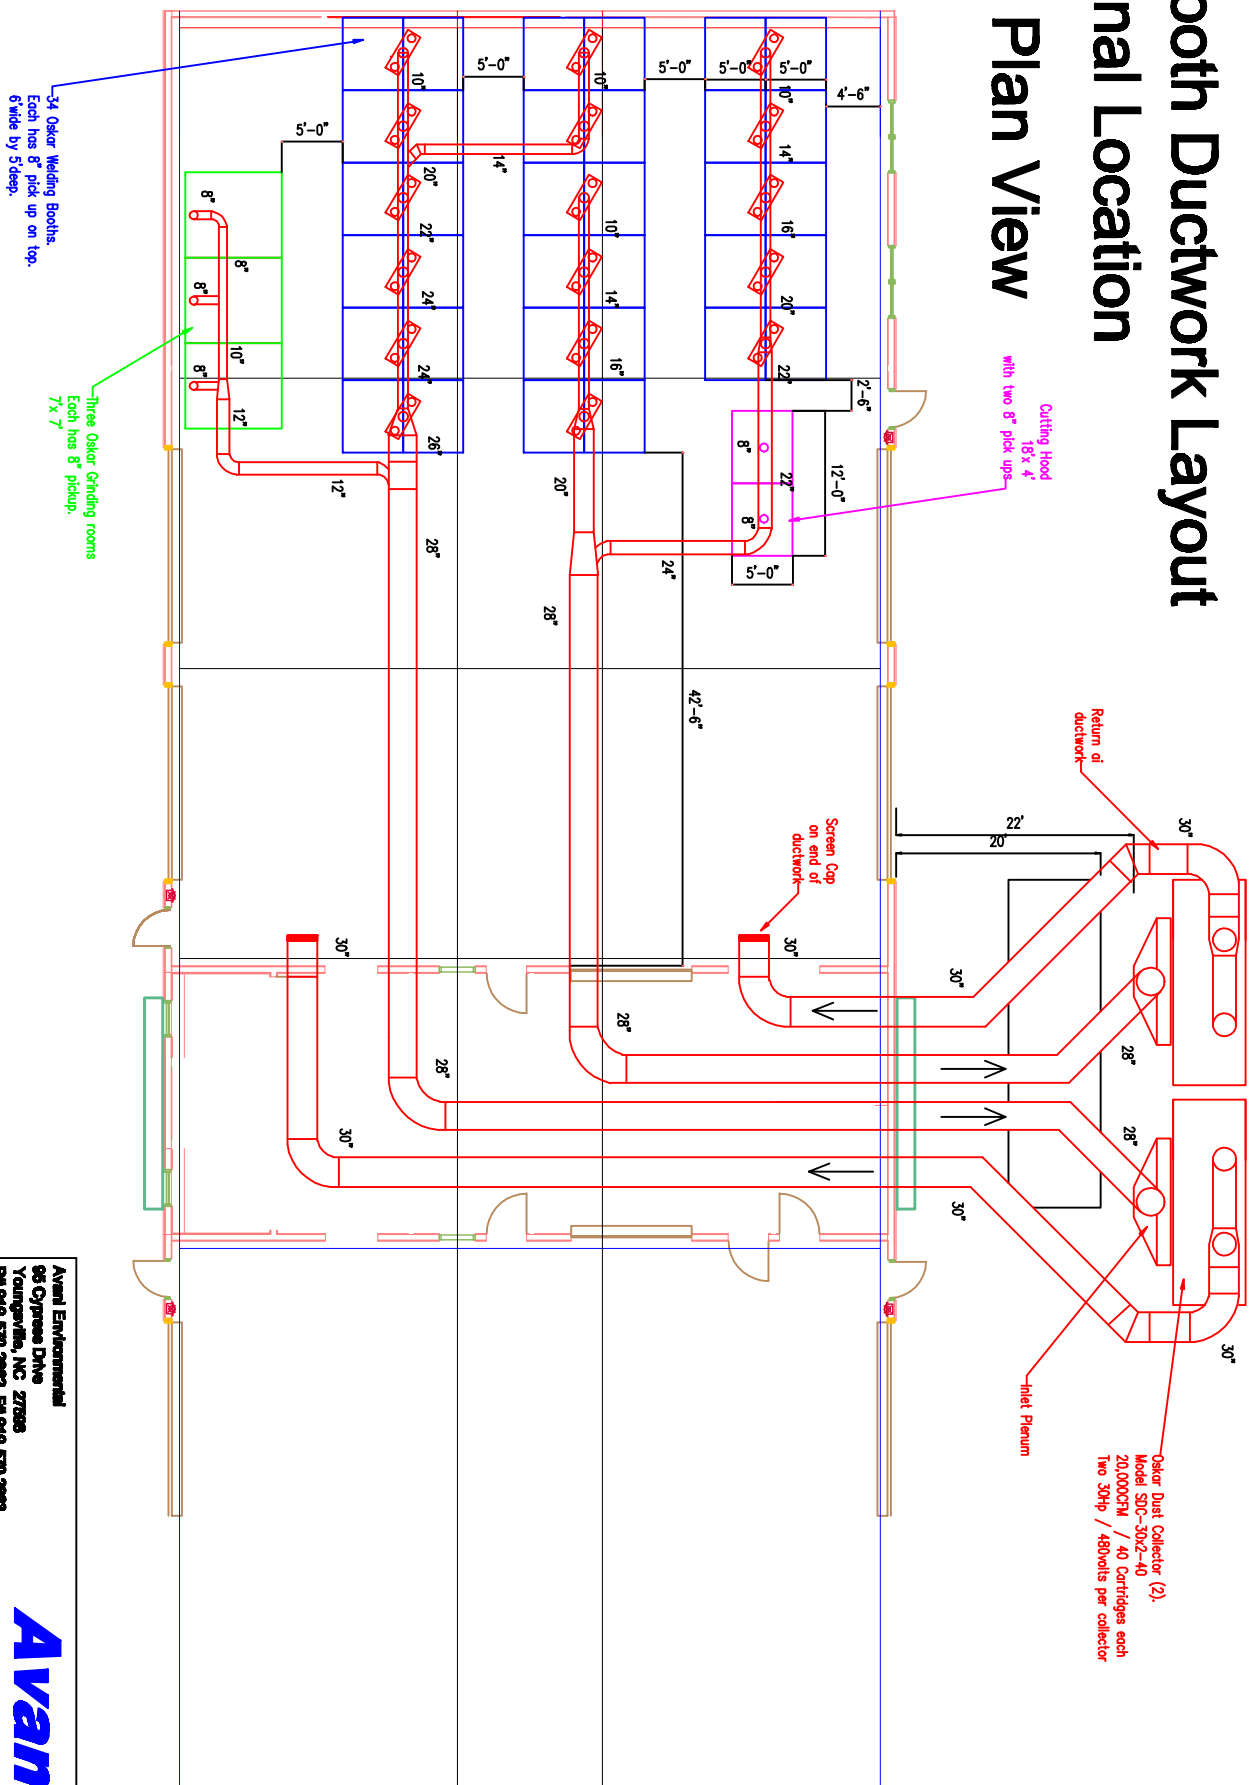

Avani Environmental
 86 Cypress Drive
 Youngsville, NC 27585
 PH 919-570-2882 FX 919-570-2883
Avani
 Project: Hartnell College
 Drawing: Ductwork Layout
 Date: 10/27/10 Drawn by: RAV
 Sheet No: