


# Plan View of Ductwork Layout Balance Drawing Head #1 - CNC Cell 1 & 2

CNC CELL #1

CNC CELL #2

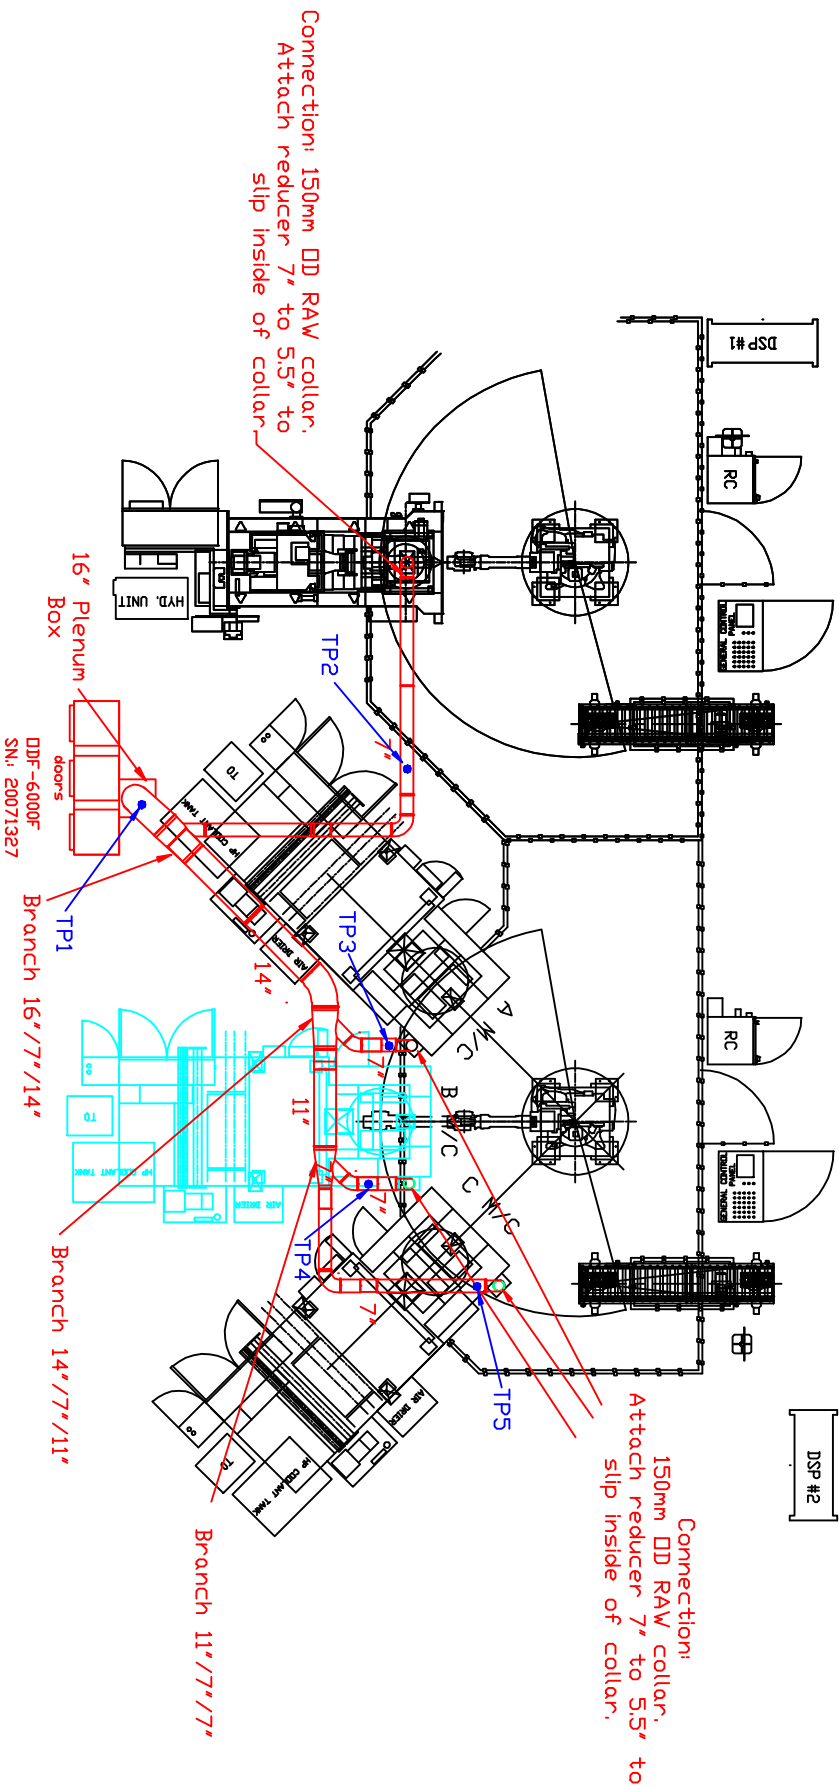

## Notes:

- A) Each drop will have a Butterfly damper for airflow adjustment.
- B) Each drop will have a Bleed in valve to allow for balancing.
- C) DDF 6000F has 3 - 3.5HP 460volt 3Phase motors. Full load amps are 4.6 amps each.
- D) Drain line: By Honda

Industrial Air Quality  
95 Cypress Dr. 27596  
Youngsville, NC F# 919-562-7182



Project: Honda Canada - Balance

Drawing: Head #1 CNC 1 & 2

Date: 09/10/08 | Drawn by: W/WB

Sheet No: 1 of 8 | Rev.: 0