



Plan View of Ductwork Layout for Dskar Collectors

Side View of Suction Hood

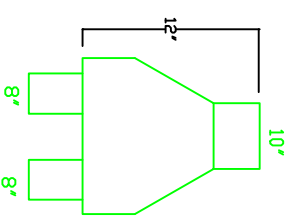

Suction Hood:
Two 8" dia. drops
to one 10" drop.

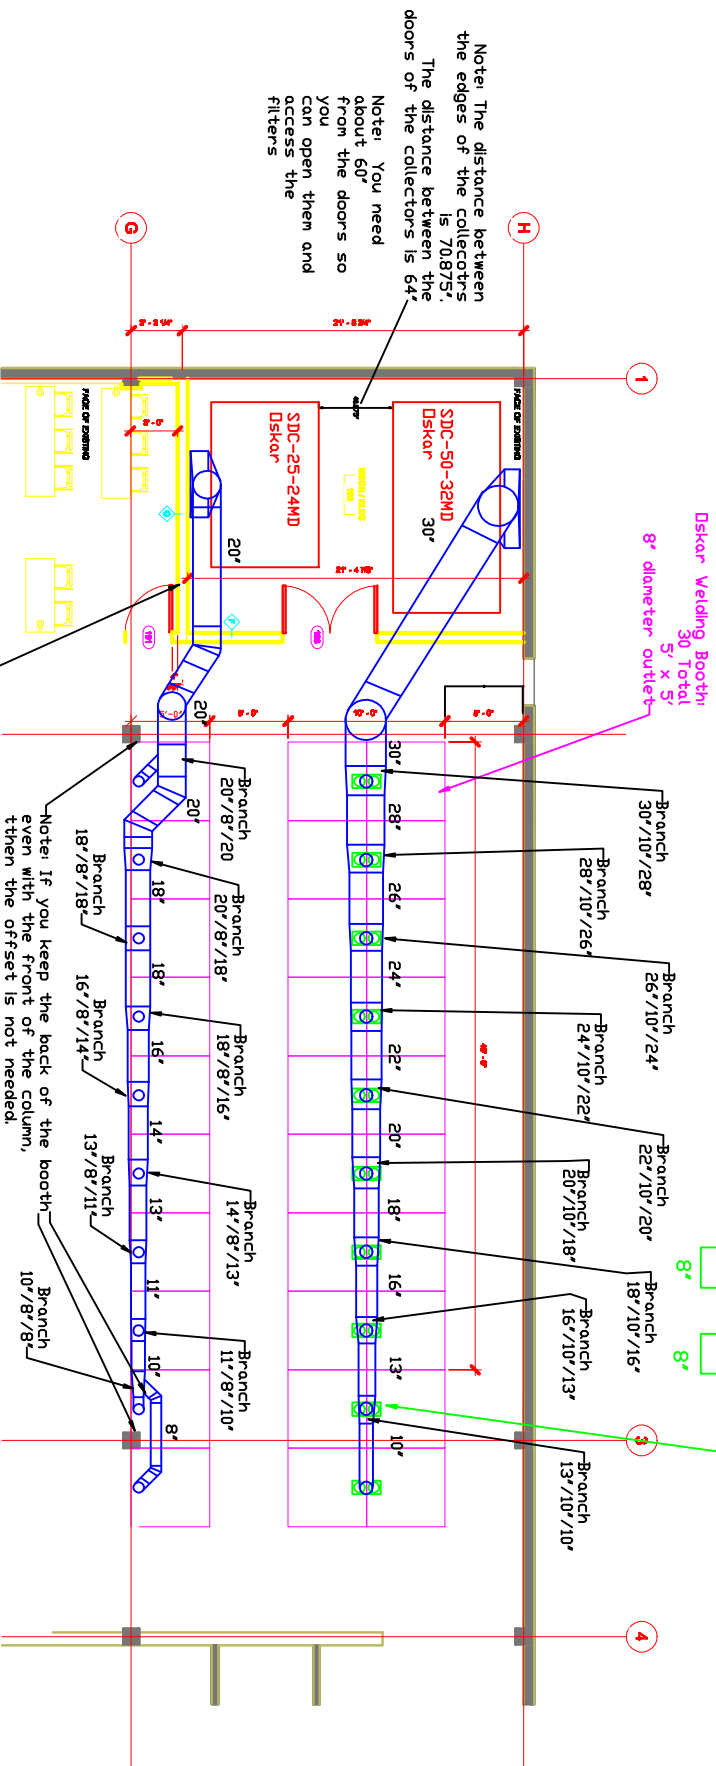

Note! The distance between the edges of the collectors is 70.875'. The distance between the doors of the collectors is 64'.

Note! You need about 60' from the doors so you can open them and access the filters

Note! If the wall between the room and the collectors is 15', then I will not need the 30 deg elbow. The ductwork can run straight.

Dskar Environmental Products
95 Cypress Drive 27596
Rougsville, NC
919-570-2862 F# 919-570-2863



Project: Medix College

Drawing: Ductwork layout
Date: 5/14/10 Drawn by: RAV

Sheet No: