



# Plan View of Ductwork Layout for Dskar Collectors

Side View of Suction Hood

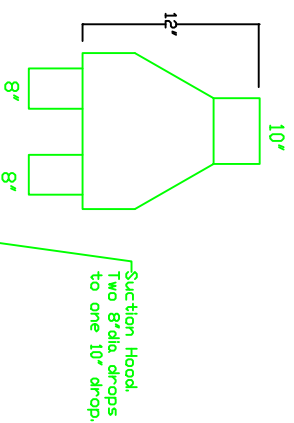

Note: You need about 60' from the doors so you can open them and access the filters

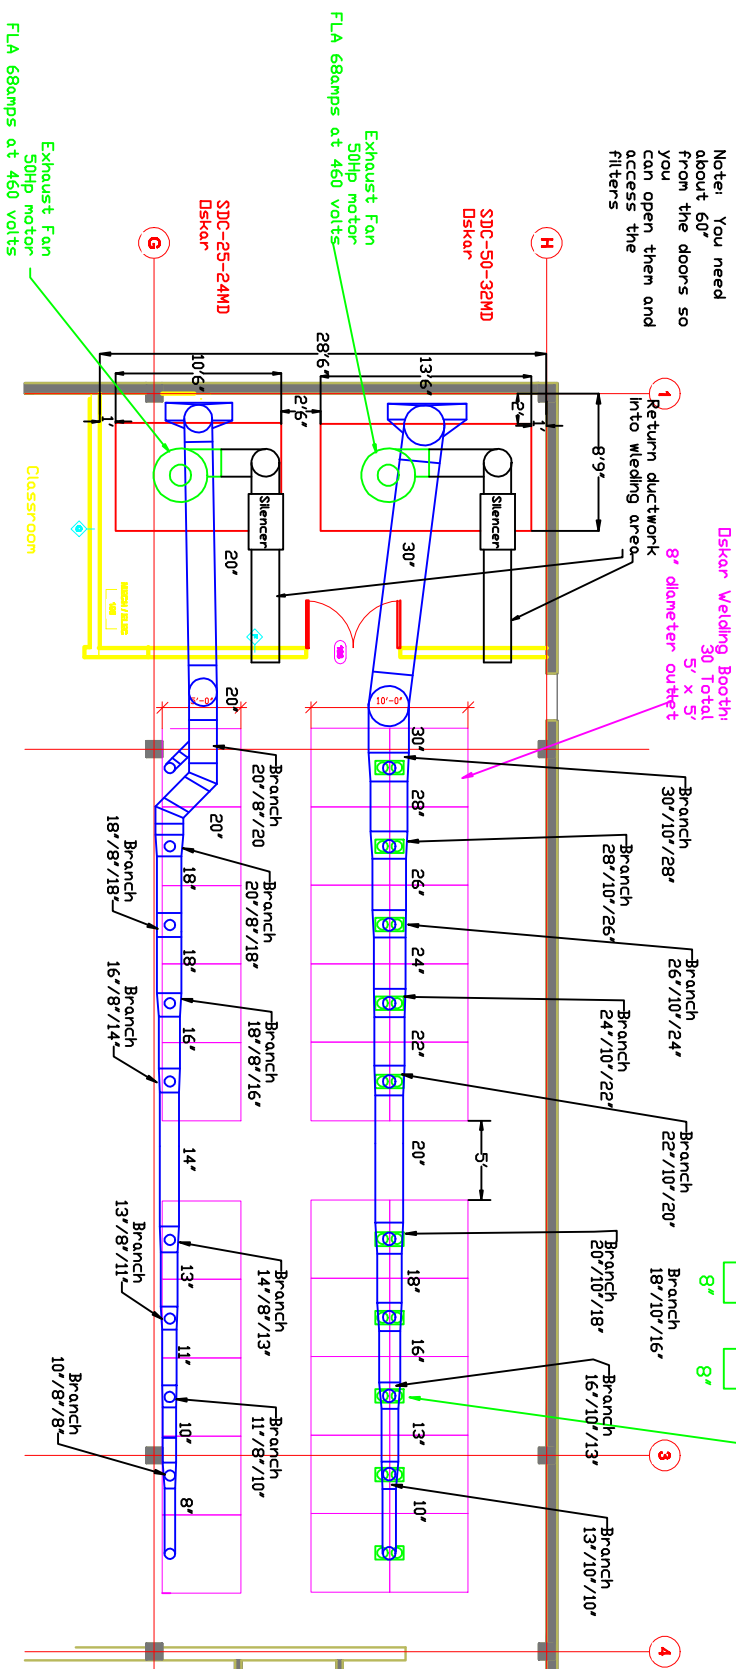

Dskar Environmental Products 95 Cypress Drive 27596 Mountsville, NC # 919-570-2862 F# 919-570-2863	
Project:	Medix College
Drawing:	Ductwork layout
Date:	6/15/10 Drawn by: RAV
Revision	2