


Avani Dust Collector Ductwork Layout

Plan View

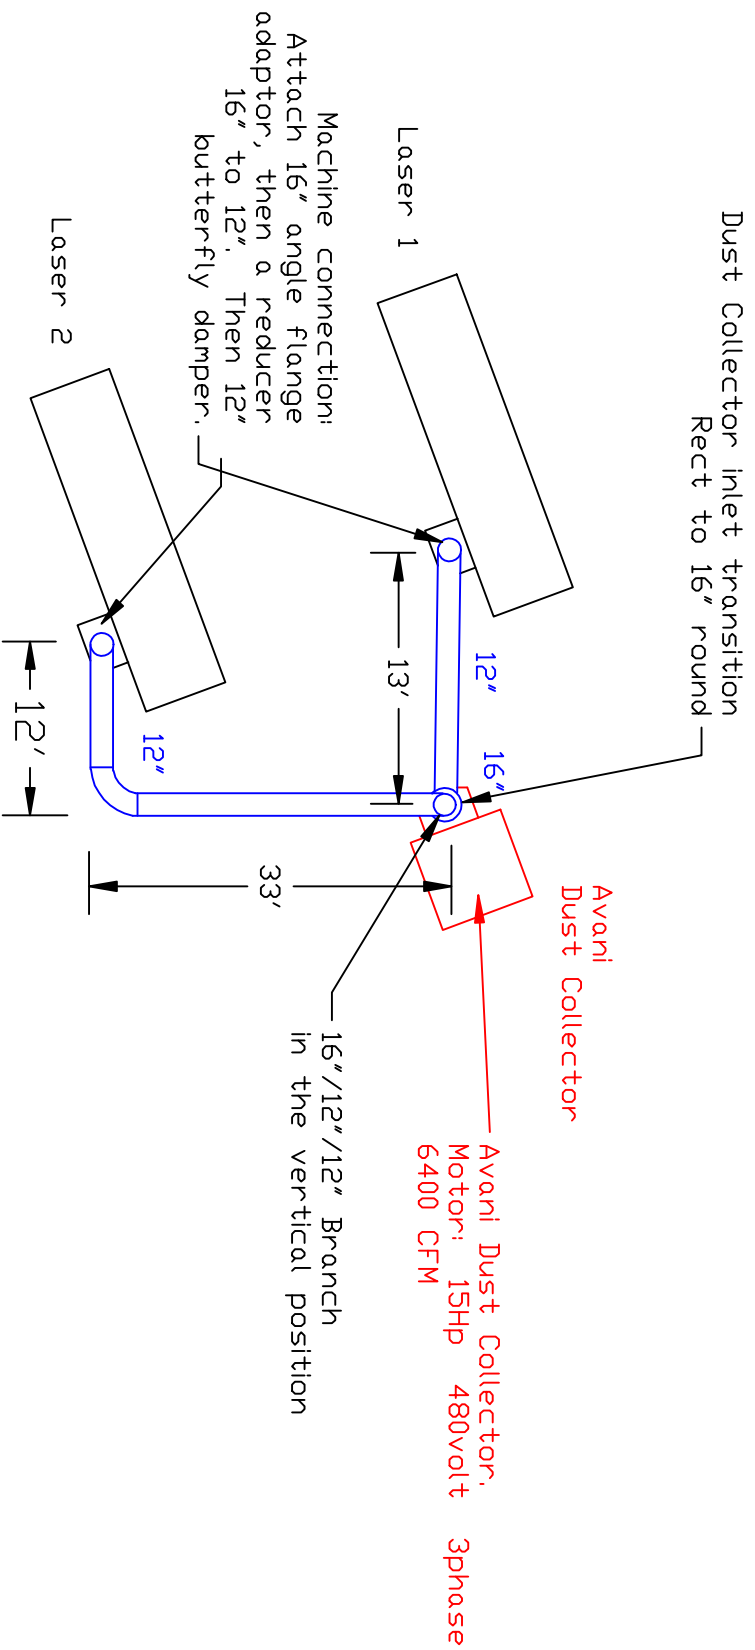

Note:
The drawing is not to scale.
The dimensions were taken from a plant layout. Just need to confirm the distances within 2 to 3 feet.

Notes:

- A) Bottom of ductwork about 18' off of the floor.
- B) Hang ductwork from ceiling.
- C) Compressed air required: 90 PSI of clean, dry air, 3/4" diameter connection.

Avani Environmental 95 Cypress Drive 27596 Raleighville, NC P# 919-570-2862 F# 919-570-2863	Avani
Project: Norco Selkirk	
Drawing: Ductwork layout	
Date: 12/13/10 Drawn by: RAV	
Sheet No:	