



Ductwork Layout

Plan View

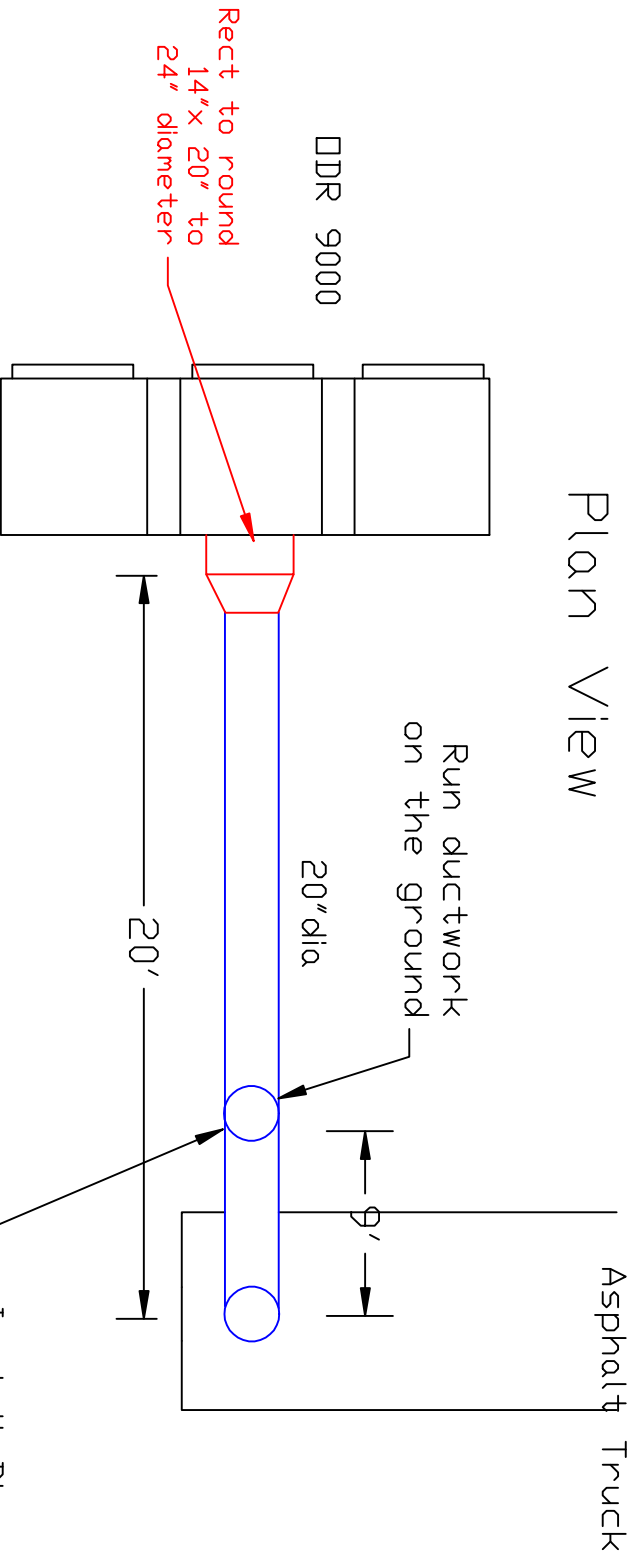

Side View

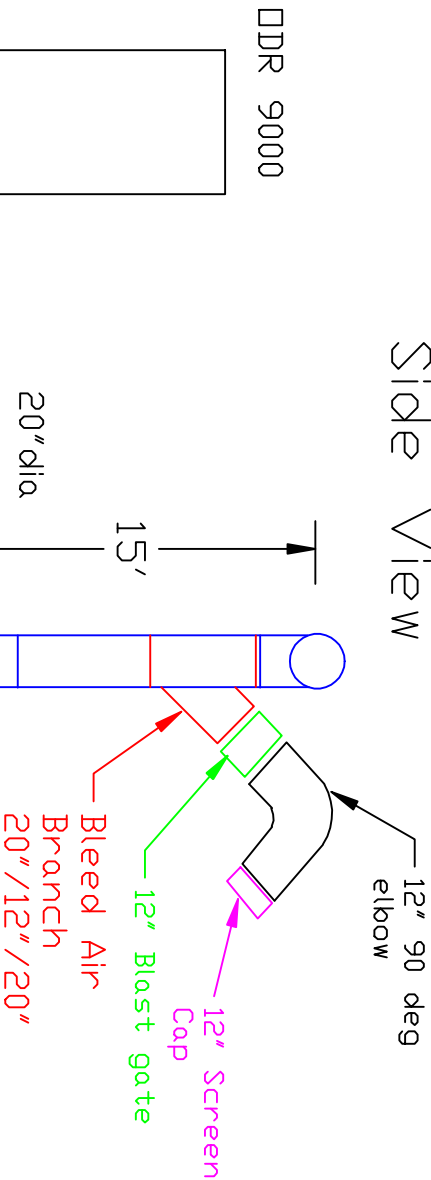

Install Bleed Air
branch in the
vertical position,
20"/12"/20" with
damper.

Avanti Environmental 95 Cypress Drive Roumaysville, NC 27596 P# 919-570-2862 F# 919-570-2863	Avani
Project: DCP Recycled Asp	
Drawing: Ductwork Layout	
Date: 4/18/11	Drawn by: RAV
Columbus Ohio	