


# Ductwork Layout for DDR 3000 Plan View

- Notes:
- A) Bottom of ductwork off of floor is 12'
  - B) Each drop will have Butterfly damper for airflow adjustment
  - C) P-Trap is Black Iron pipe / 3/4" diameter.

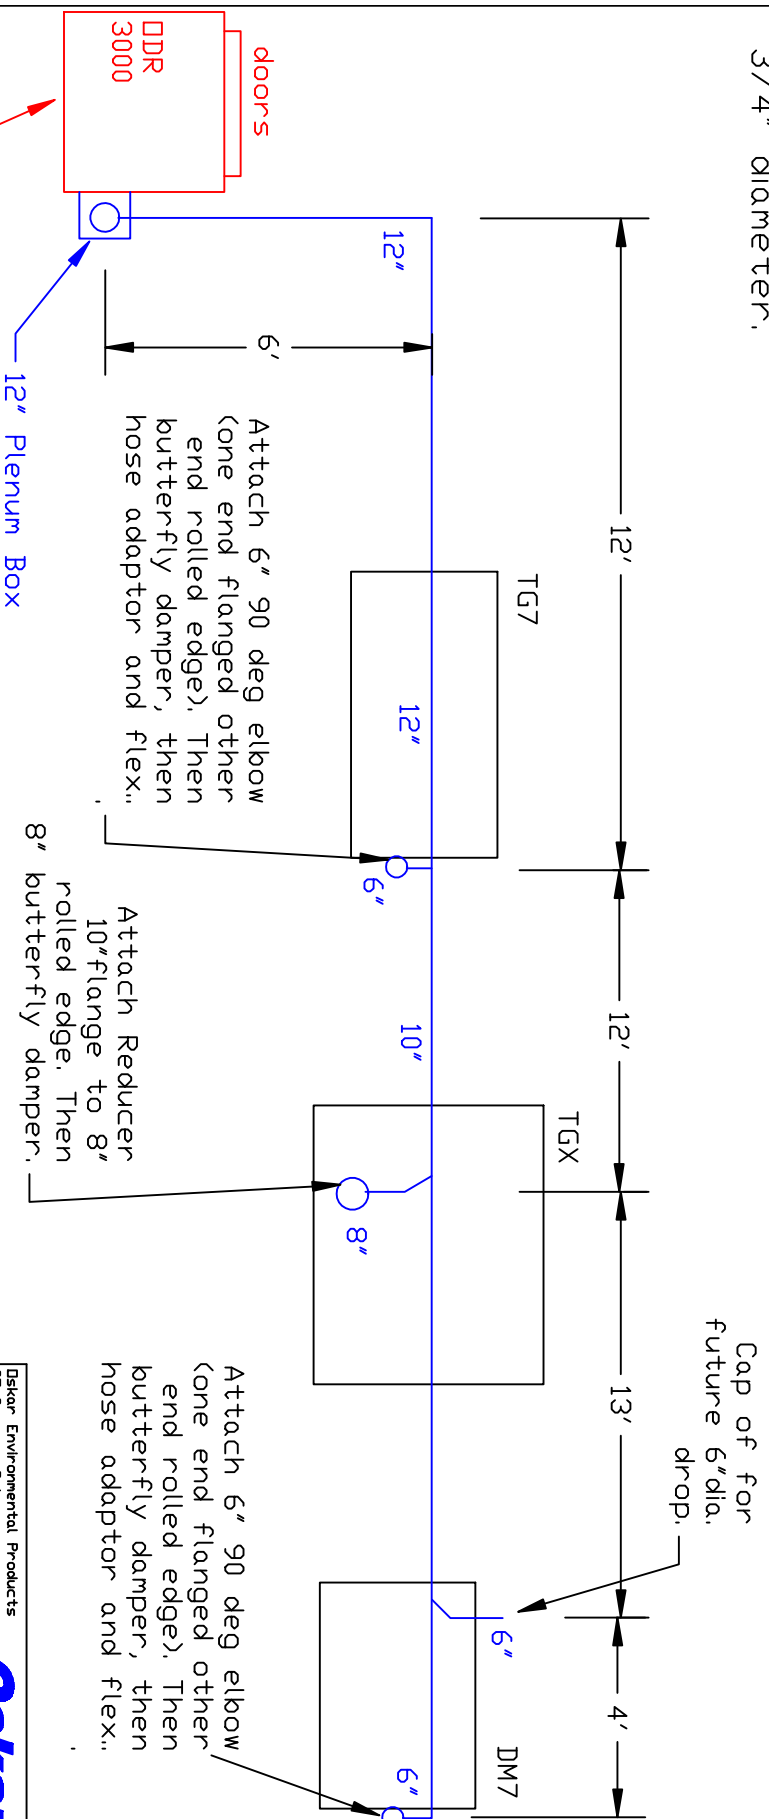

Dixkar Environmental Products	
95 Cypress Drive	27596
Mountsville, NC	
# 919-570-2862	F# 919-570-2863
<b>Oskar</b>	
Project: Smith & Nephew	
Drawing: Ductwork Layout	
Date: 3/19/10	Drawn by: RAV
Sheet No:	