


Ductwork Layout for new Junker

Plan View

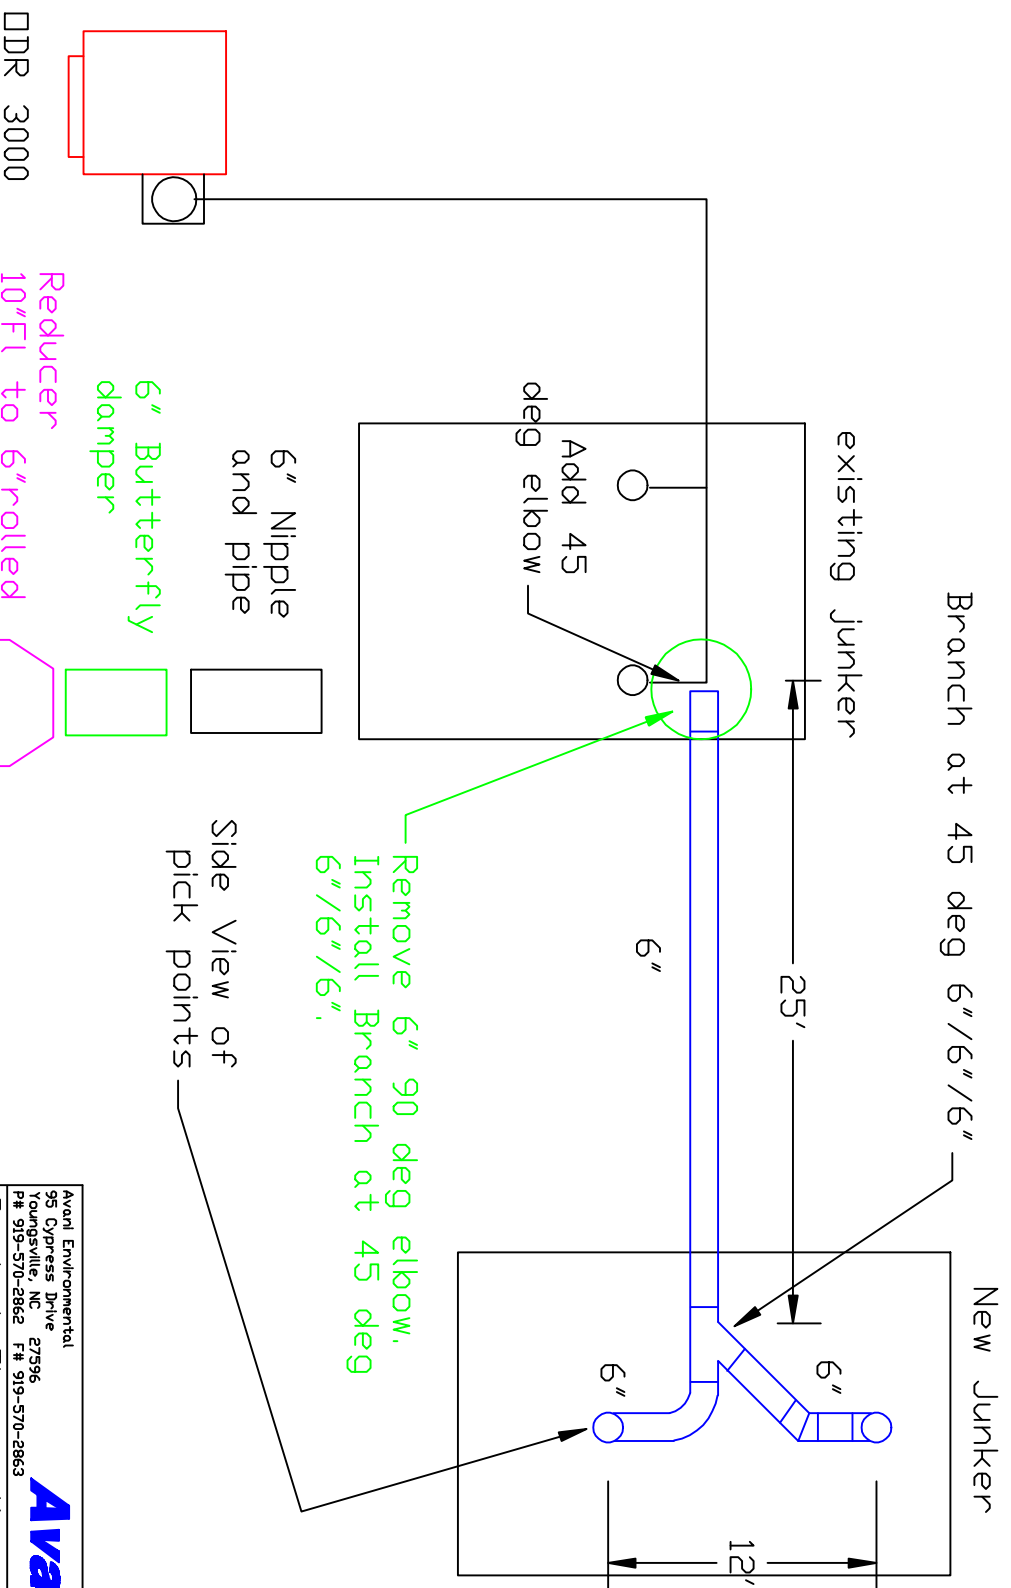

Avanti Environmental 95 Cypress Drive 27596 Raleighville, NC P# 919-570-2862 F# 919-570-2863	Avani
Project: Thyssen Kruupp	
Drawing: Ductwork layout	
Date: 11/3/11	Drawn by: RAV
Sheet No:	