


Absolent Ductwork Layout

Side View

Duct Layout for Future Machine

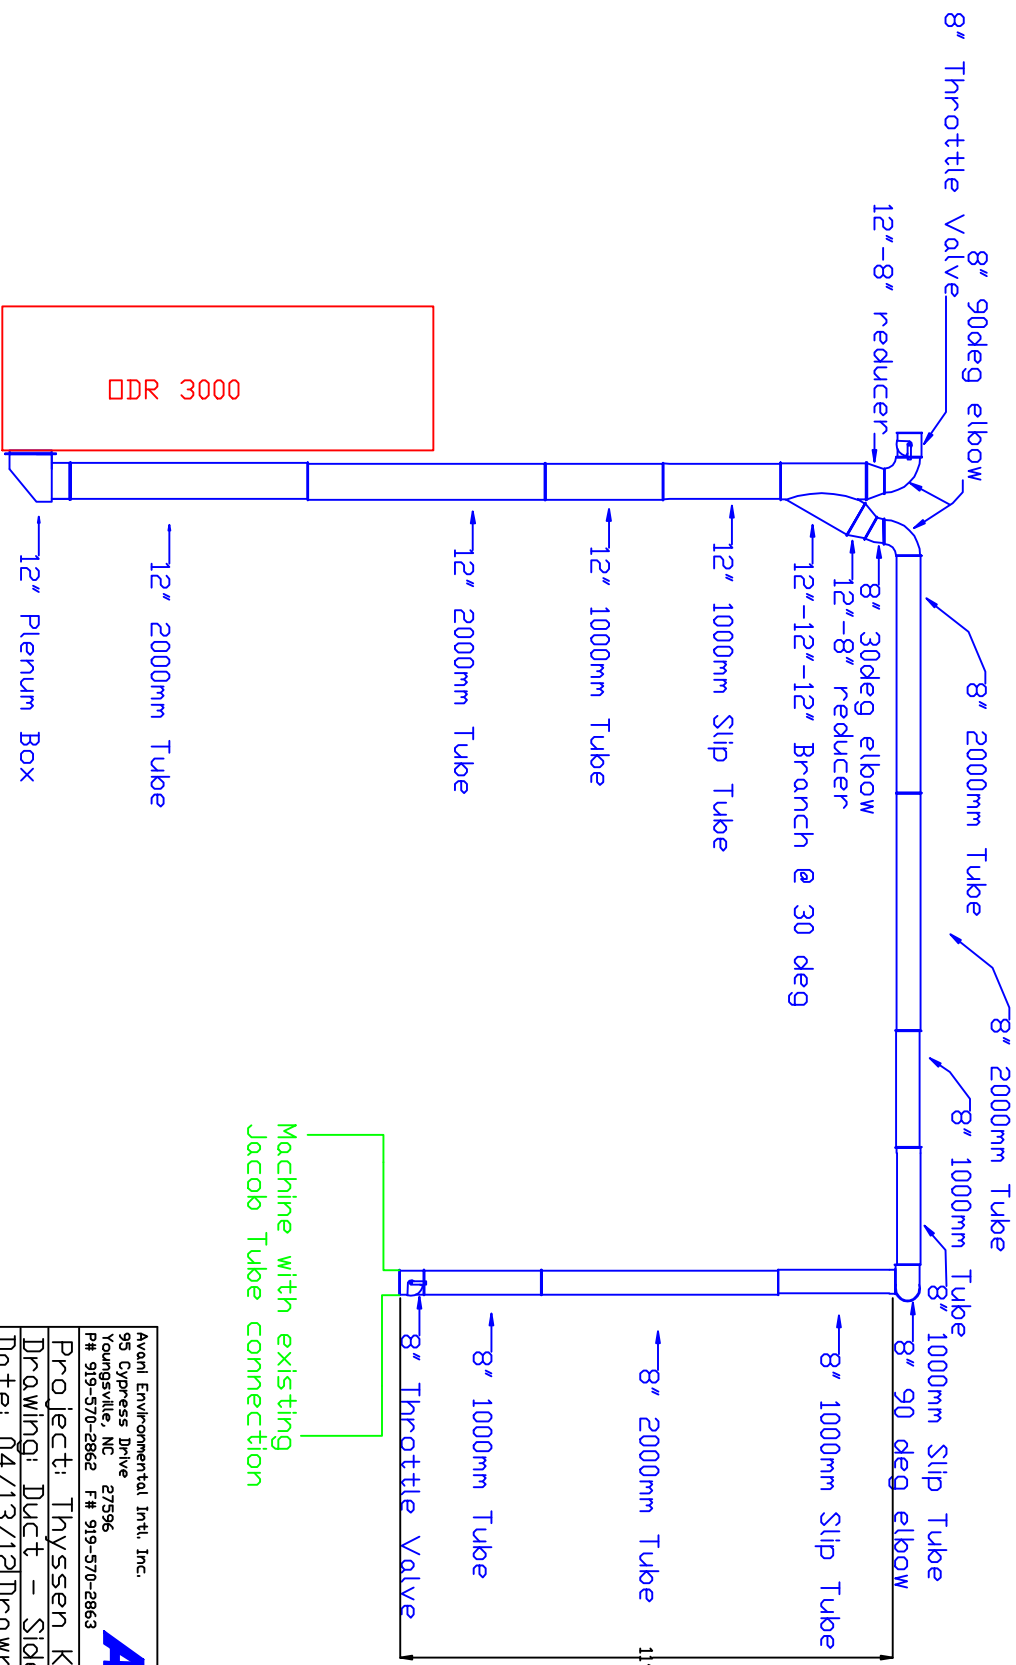

Avani Environmental Intl. Inc.
95 Cypress Drive
Youngsville, NC 27596
Ph 919-570-2862 F# 919-570-2863
Avani
Project: Thyssen Krupp
Drawing: Duct - Side View
Date: 04/13/12 Drawn by: DJJ
Sheet No: