


Ductwork / Booth Layout Plan View

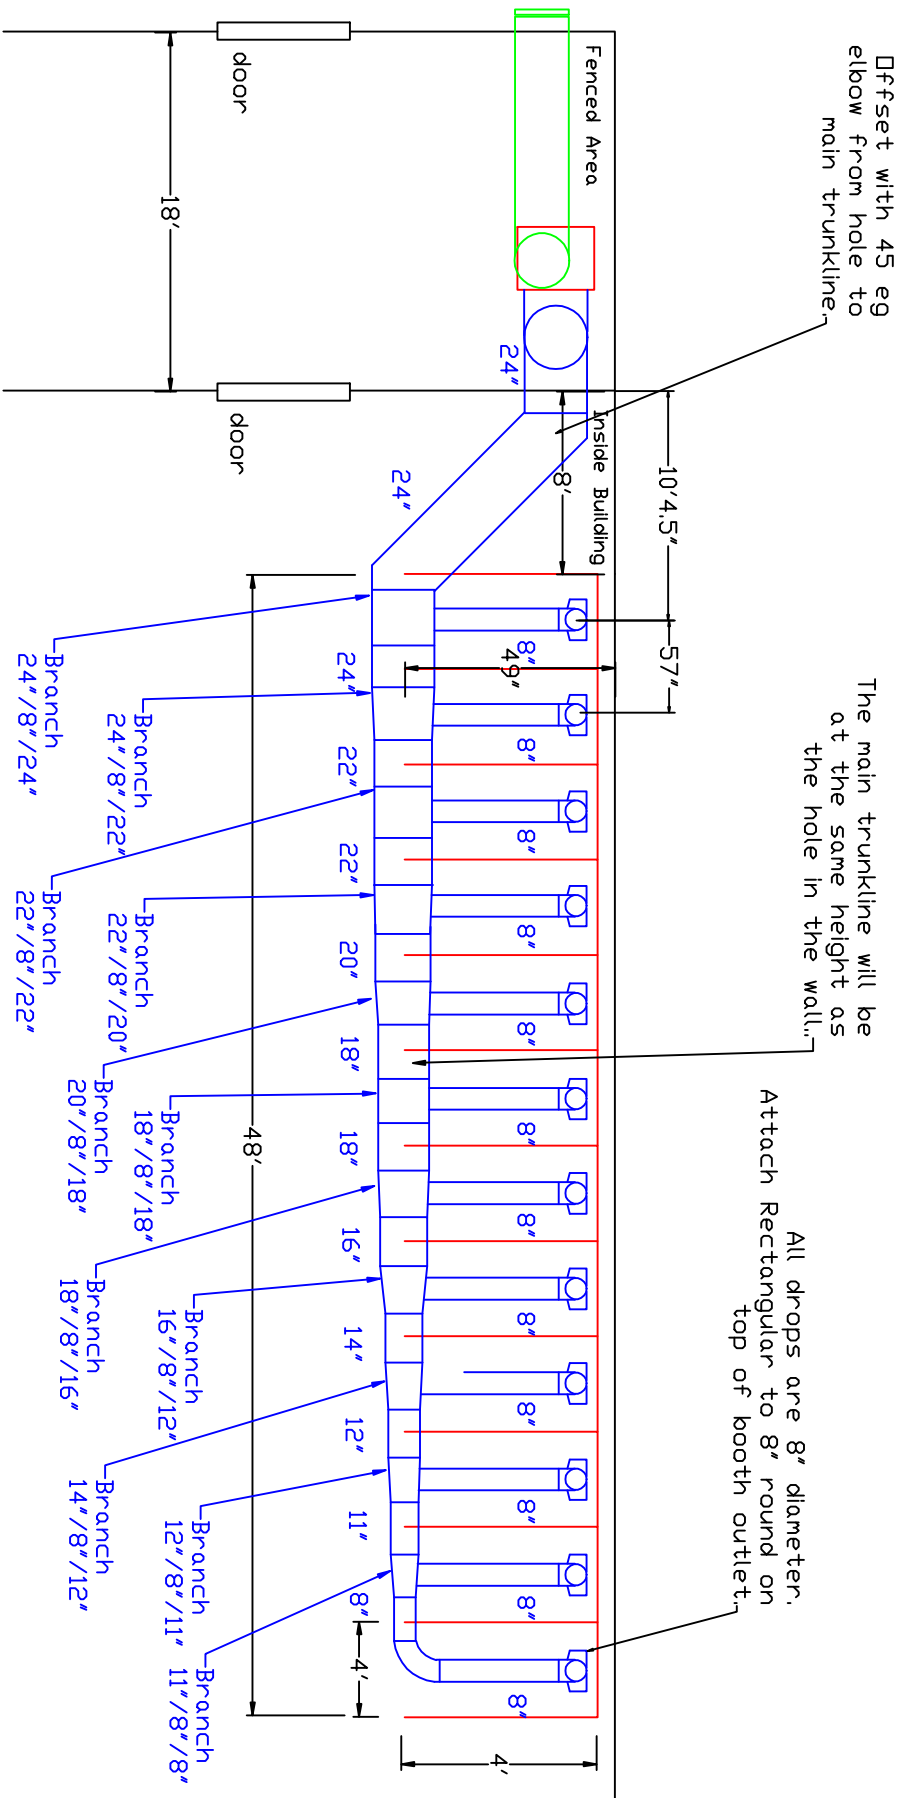

Industrial Air Quality
102 A2 DRIVE
Youngsville, Nc 27596
P# 919-562-7181 F# 919-562-7182
Project: West Point Tech
Drawing: Ductwork layout
Date: 10/2/09 Drawn by: RAV

