


# Ductwork / Booth Layout

There will be an offset to lower the ductwork so as to fit through the wall opening.

Plan View

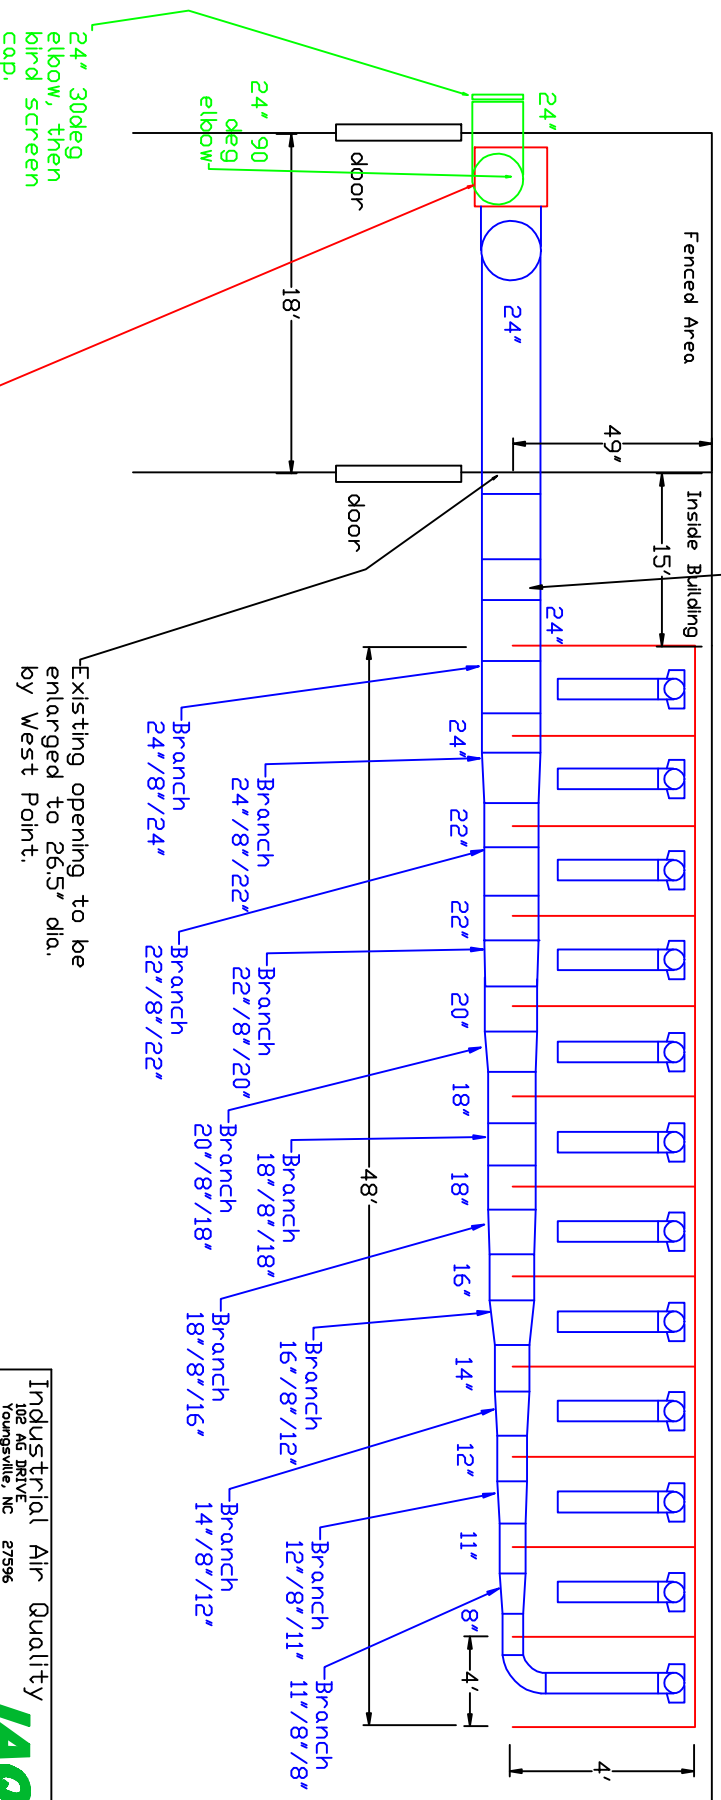

24" 30deg elbow, then bird screen cap.

Oskar exhaust fan: 25HP 230volts

Existing opening to be enlarged to 26.5' dia. by West Point.

Industrial Air Quality
102 AG DRIVE
Toungesville, NC 27596
Ph: 919-562-7181 F: 919-562-7182
<b>IAQ</b>
Project: West Point Tech
Drawing: Ductwork layout
Date: 10/2/09 Drawn by: RAV