


Ductwork Layout for A-Mist

Side View

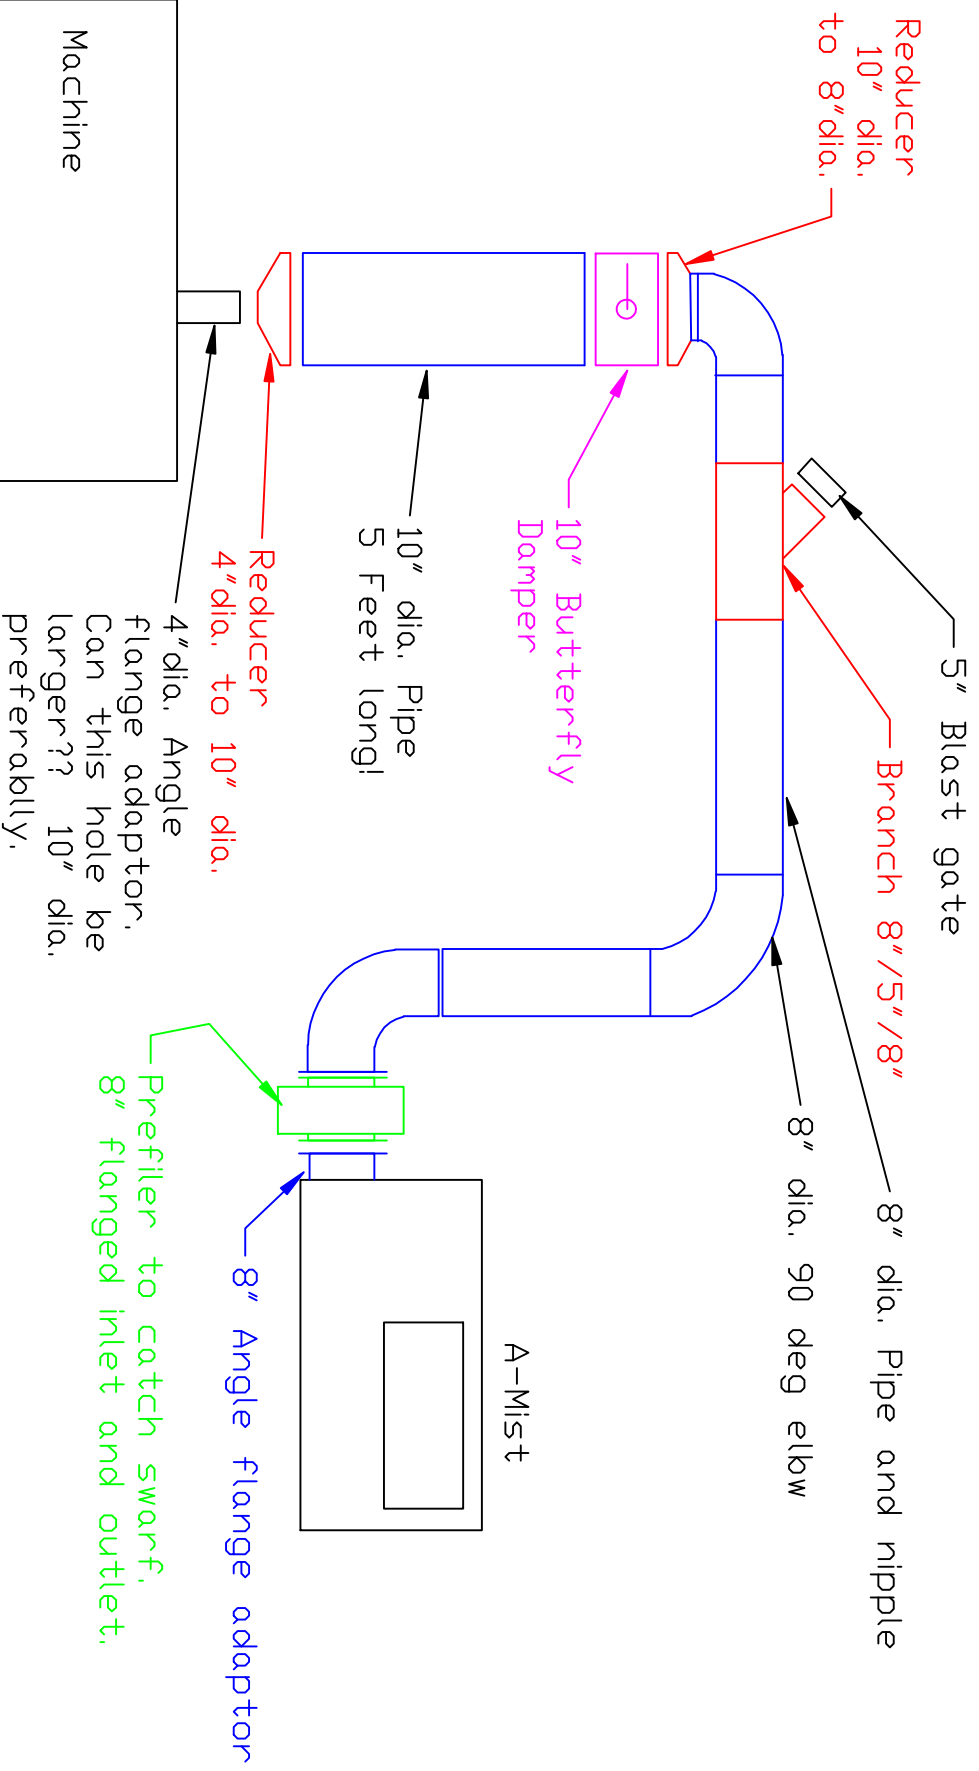

Avanti Environmental 95 Cypress Drive 27596 Roumbsville, NC P# 919-570-2862 F# 919-570-2863	Avani
Project: Whirlpool	
Drawing: Ductwork layout	
Date: 10/18/11 Drawn by: RAV	
Sheet No:	