


DDF 1000C Ductwork Layout for ACME #2

Plan View

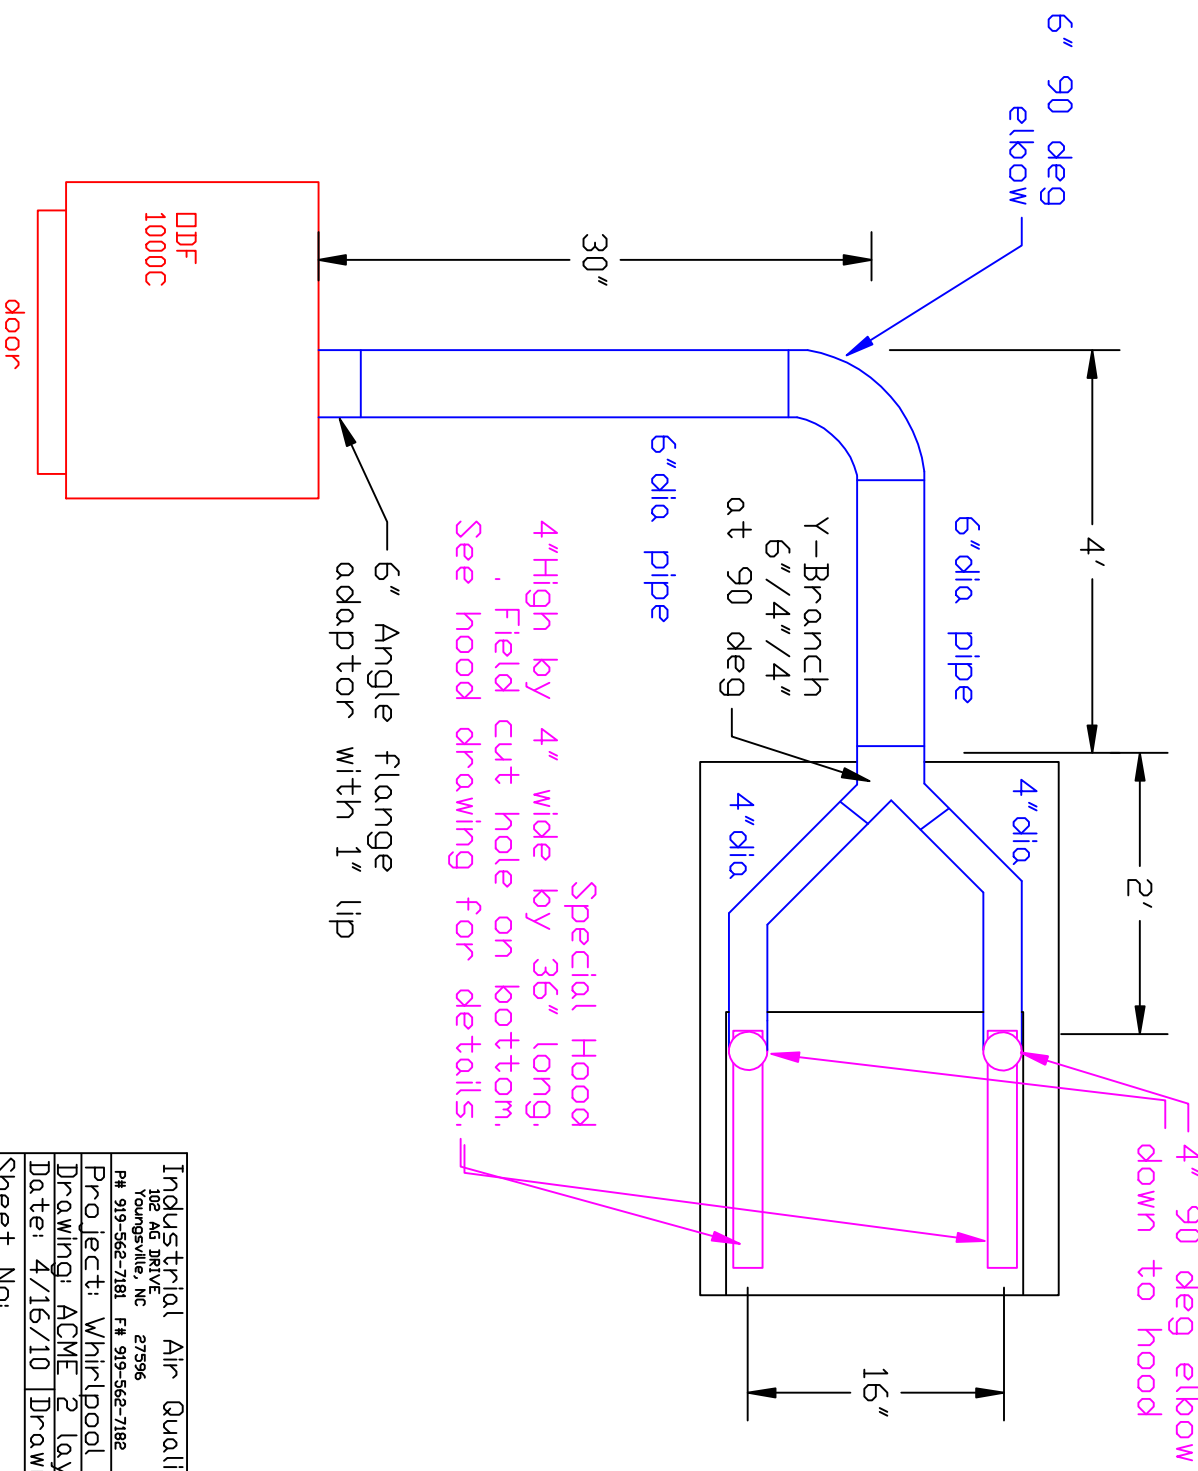

Industrial Air Quality
102 AG DRIVE
Toungesville, NC 27596
PH 919-562-7181 F# 919-562-7182
Project: Whirlpool
Drawing: ACME 2 layout
Date: 4/16/10 Drawn by: RAV
Sheet No:

