


# Accent Cabinetry Duct Layout

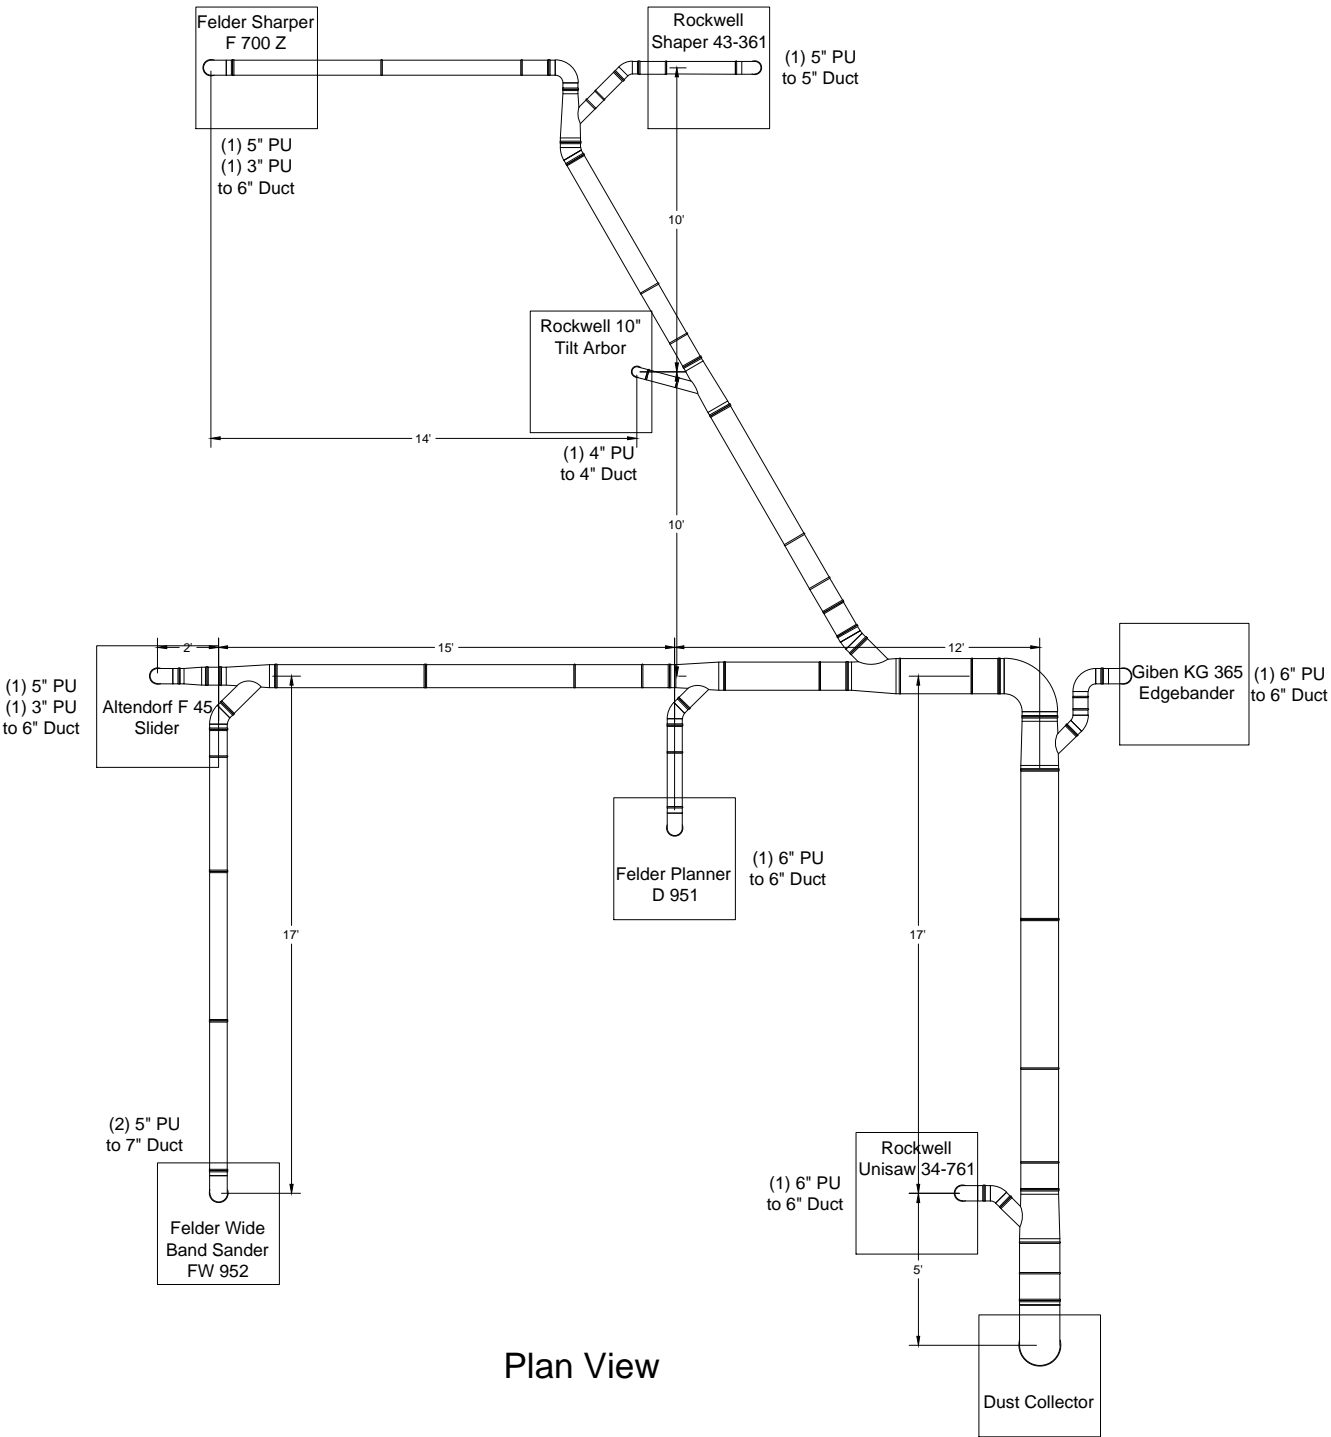

Plan View

- Notes**
1. Dust Collector - Bag house
  2. Duct at 15' elevation, flex duct starts at 5' elevation

Avani Environmental 95 Cypress Drive Youngsville, NC 27596 P# 919-570-2862 F# 919-570-2863		
<b>Project: Accent Cab</b>		
<b>Drawing: Ductwork layout</b>		
Date: 12/3/13	Drawn by: MDT	
Sheet No:		